

# TROY GARDENS


## Planned Unit Development Site Improvements

November 23, 2005

### Sheet List Table

No.	Sheet Title
100	Existing Conditions
101	Site Preparation and Erosion Control Plan
102	Street and Parking Layout Plan
103	Street and Parking Layout Plan
104	Walkway Layout Plan
105	Site Grading and Drainage Plan
106	Utility Plan
107	Landscaping Plan
108	Lighting Plan
109	Signing and Pavement Marking Plan
110	Details
111	Landscape Details

PROJECT LOCATION

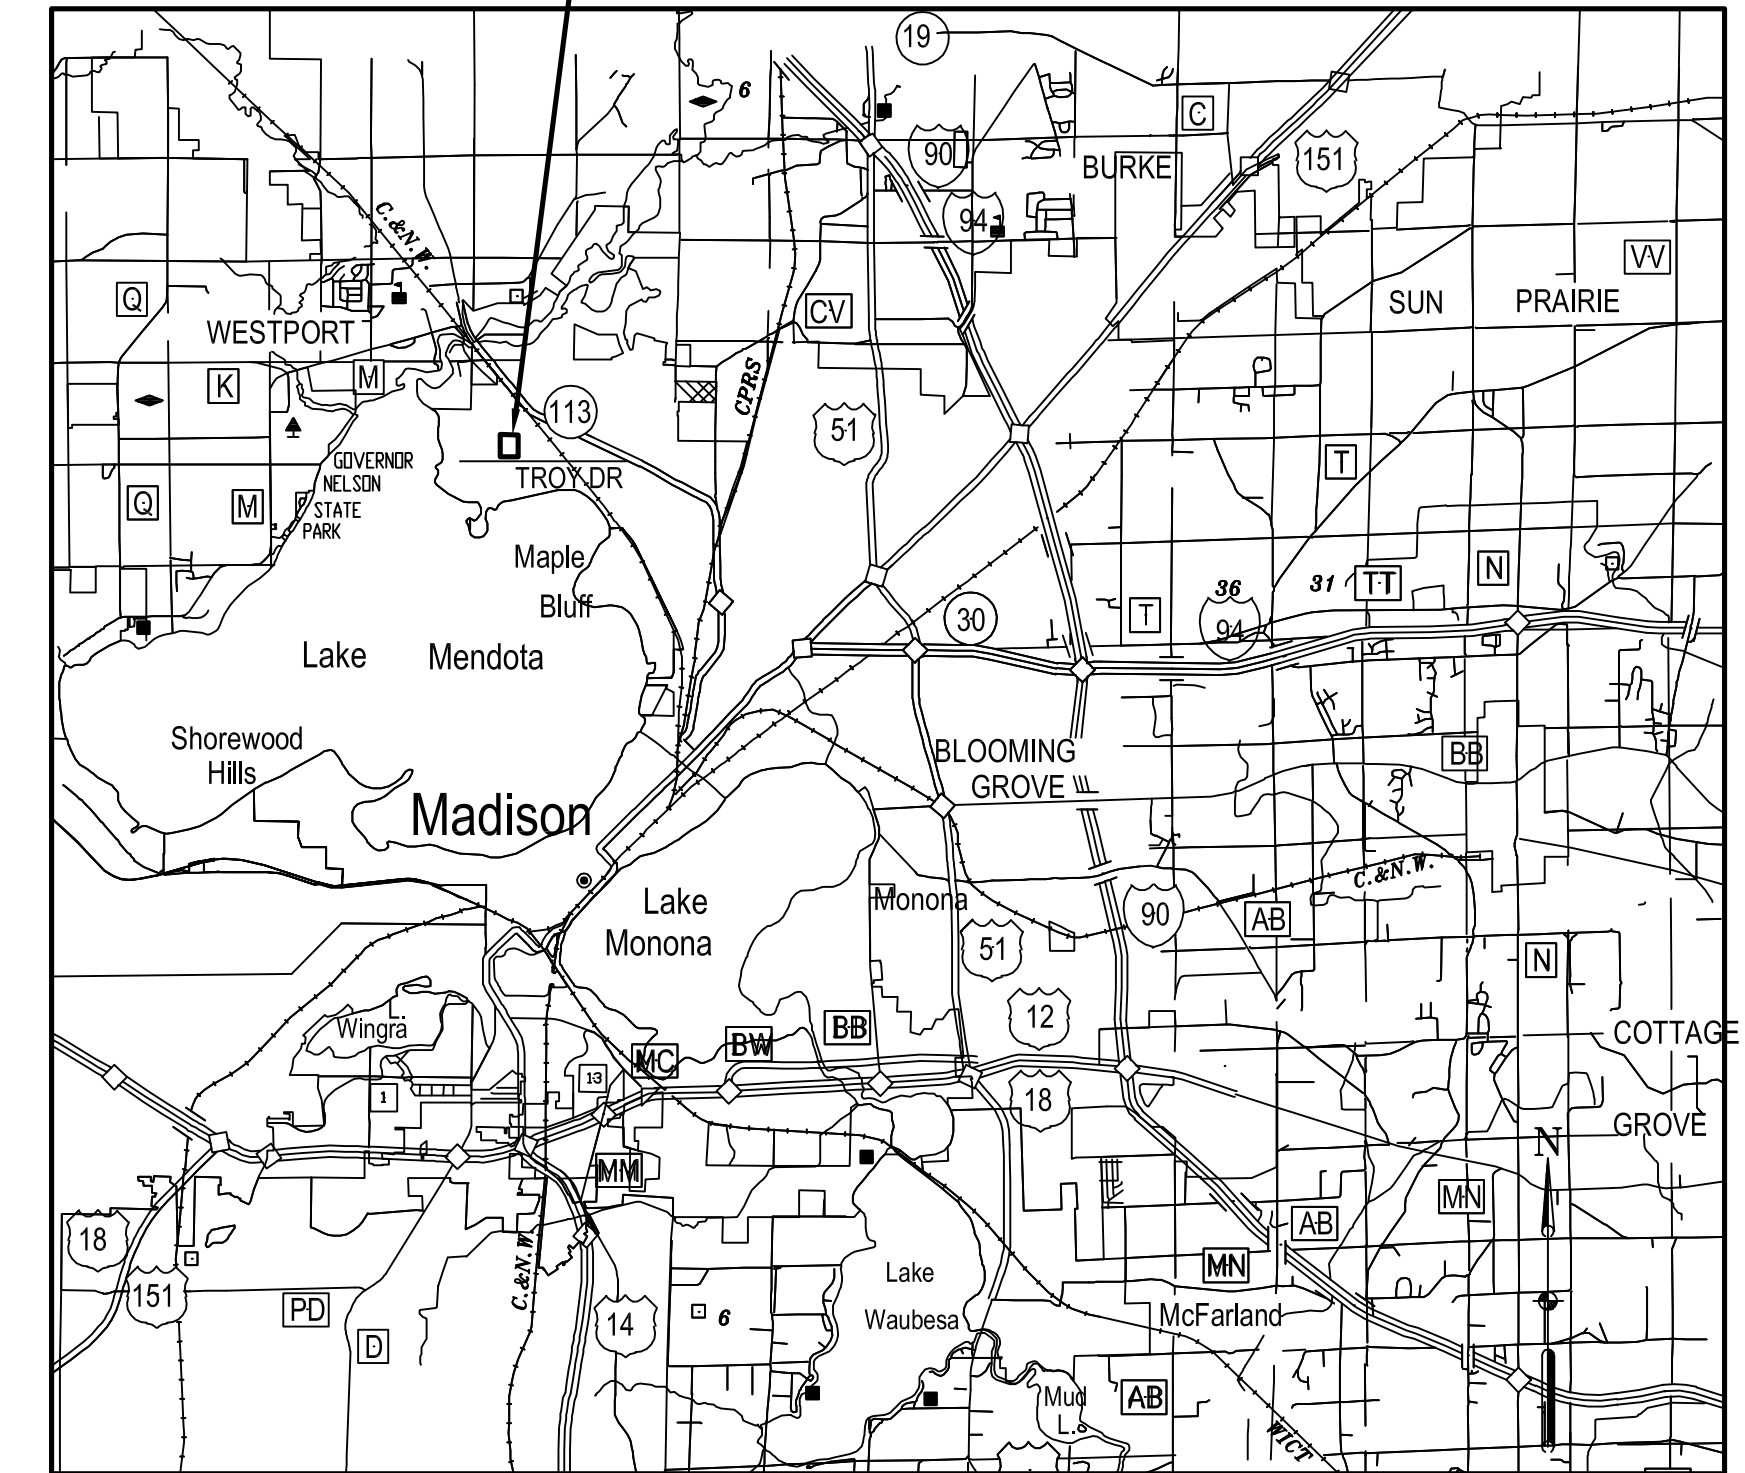

LOCATION MAP

Owner:

**Madison Area  
CLT Corporation**

305 South Paterson Street  
Madison, Wisconsin 53703

Consultant:

**JJR** landscape architecture  
planning  
urban design  
civil engineering  
environmental science

JJR, LLC  
625 WILLIAMSON STREET  
MADISON, WI 53703  
608.251.1177 T  
608.251.6147 F  
www.jjr-us.com